

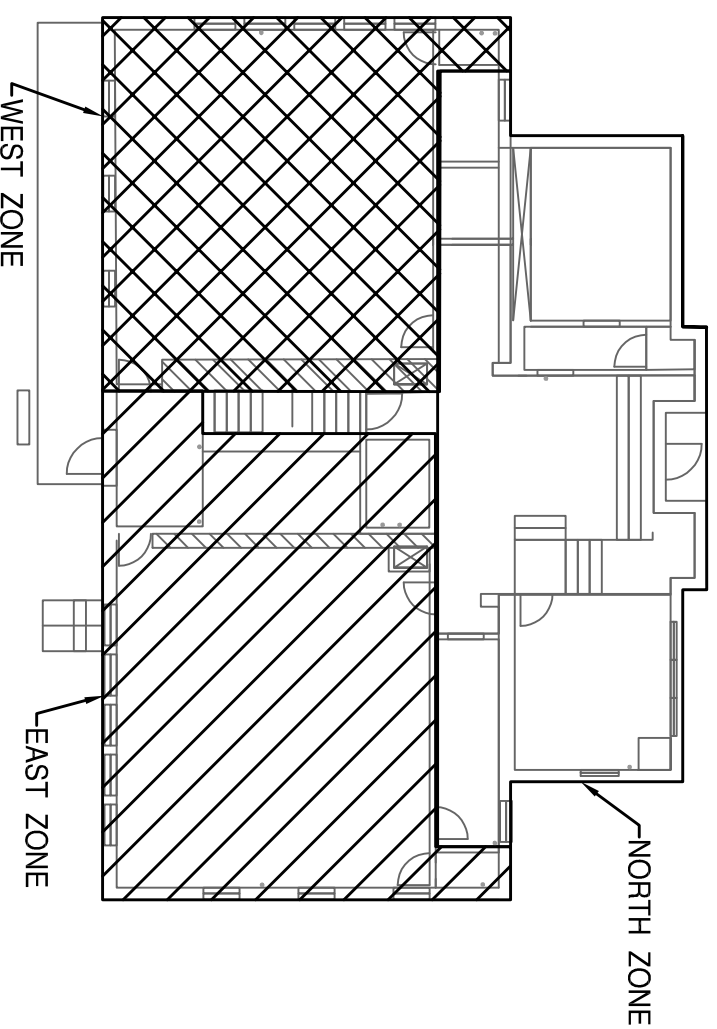


1ST FLOOR HEATING-COOLING ZONE PLAN

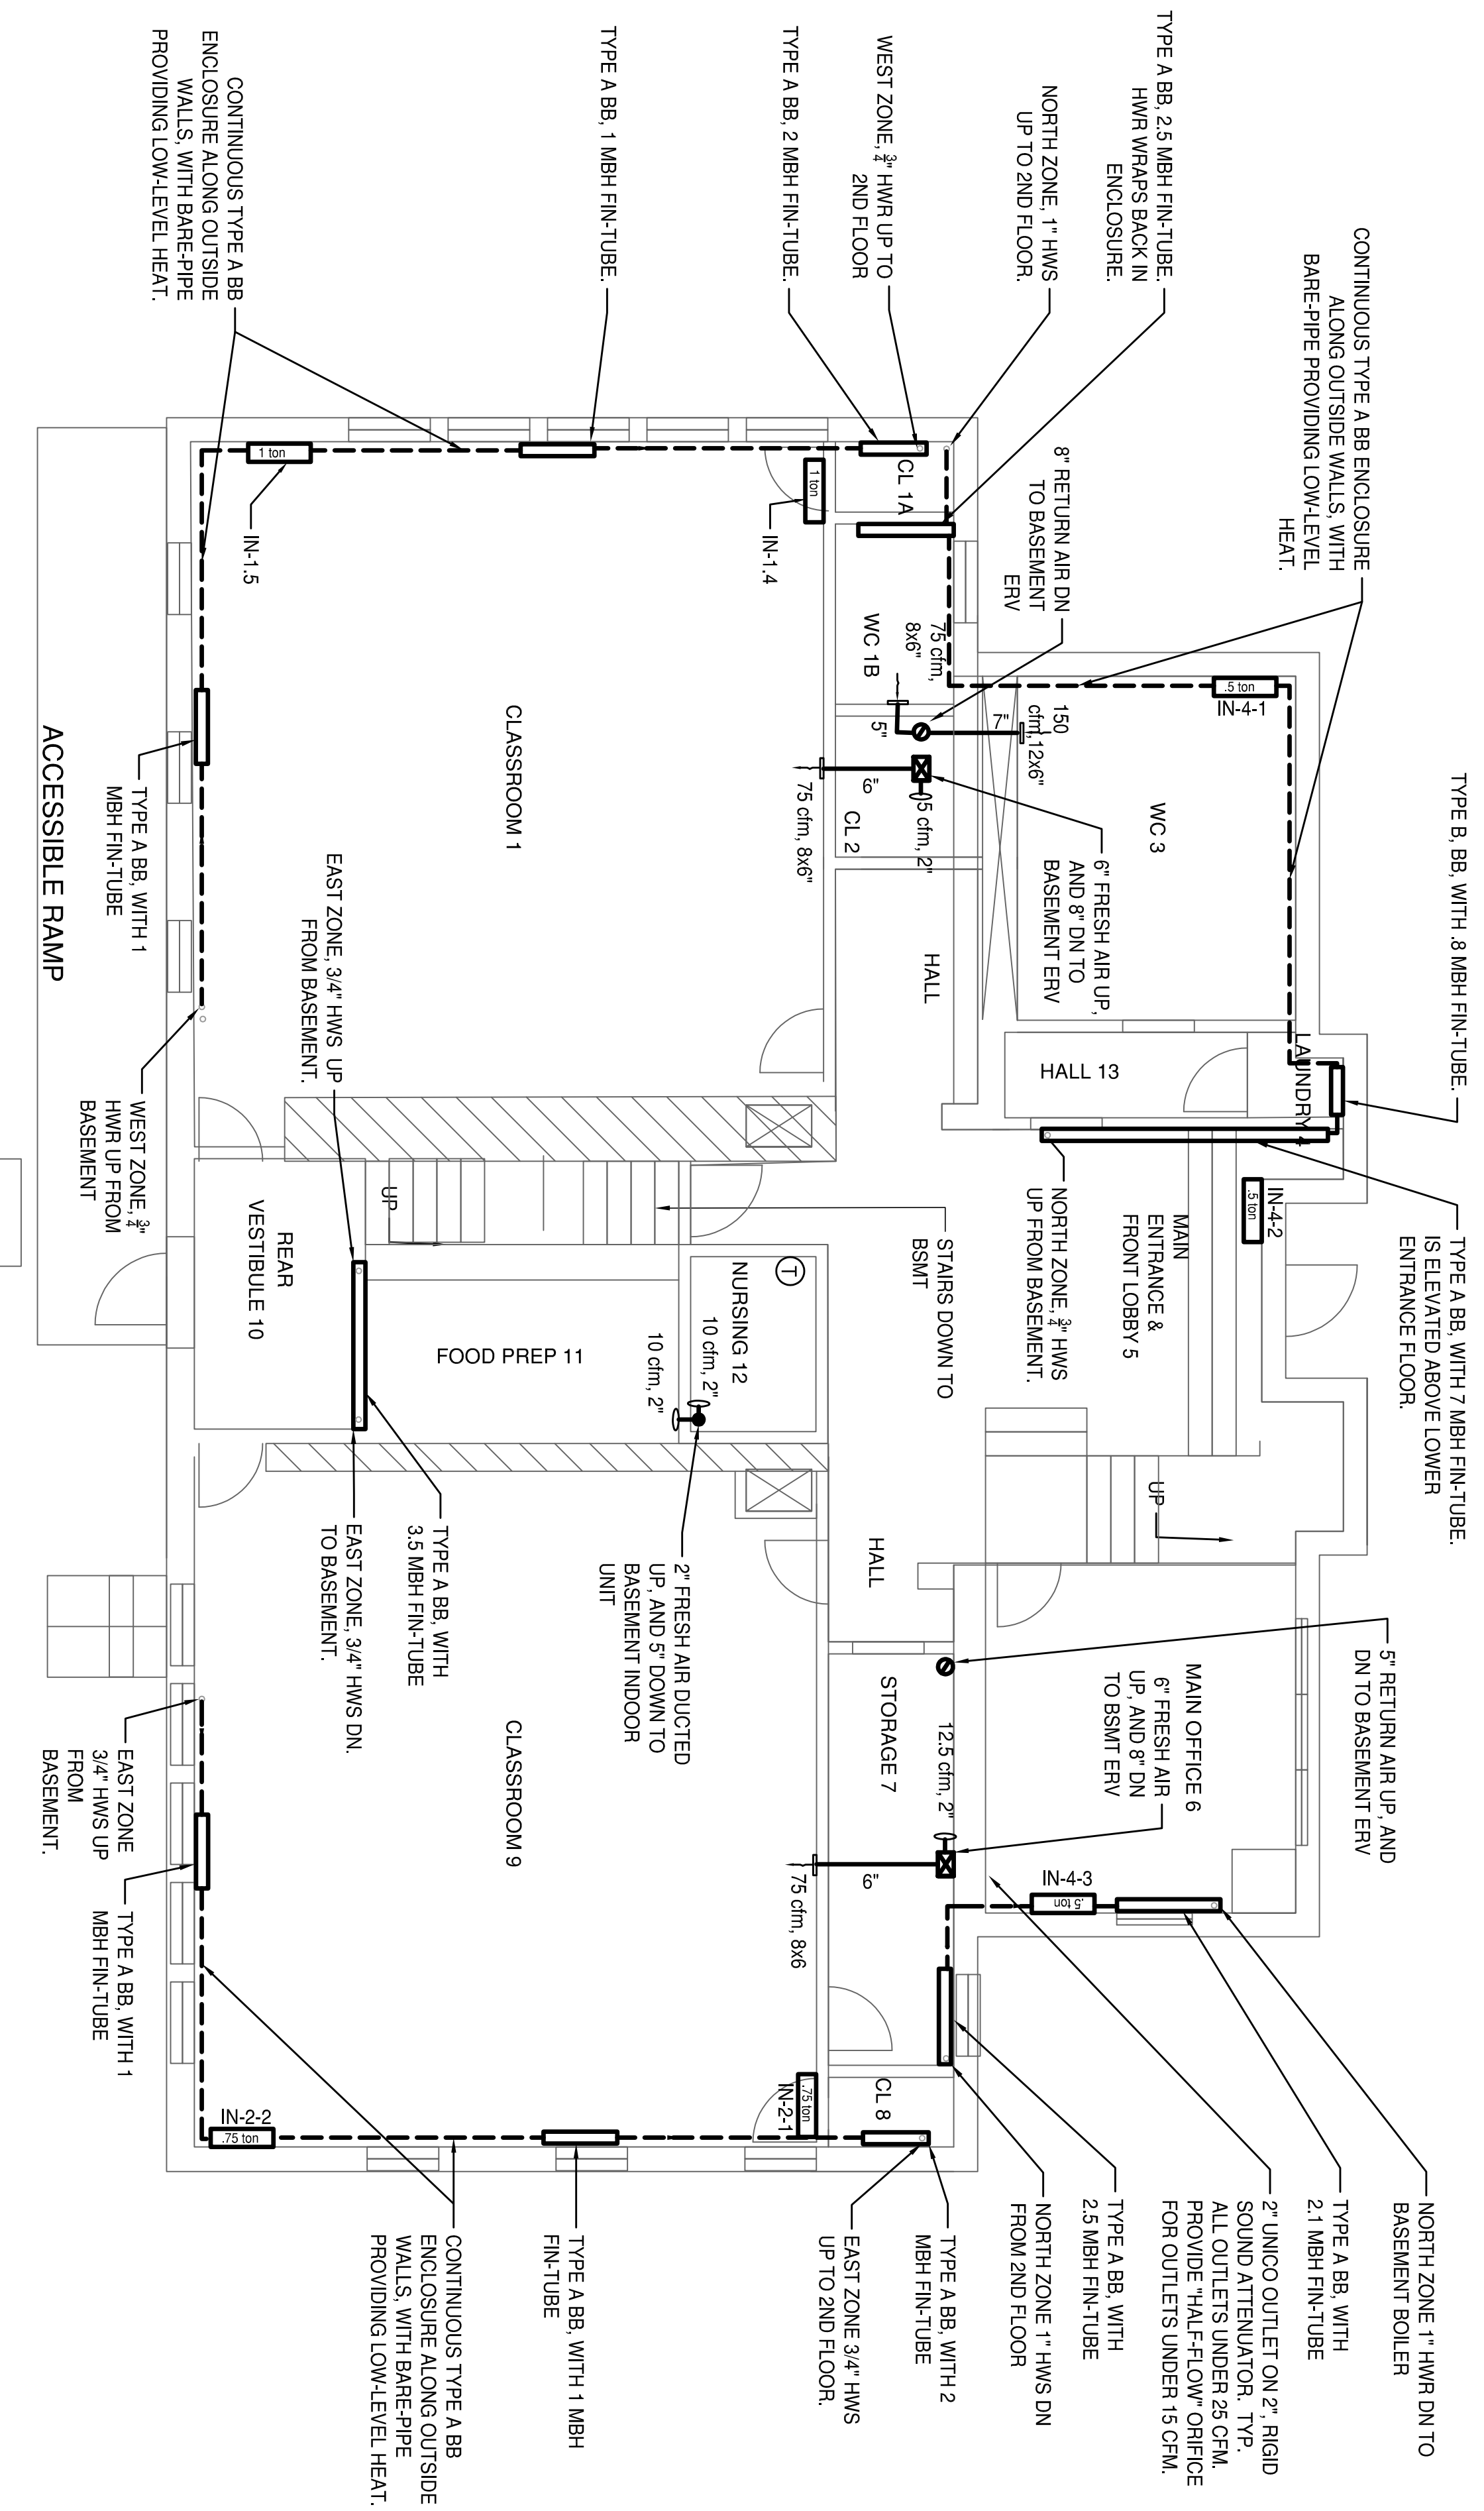

1ST FLOOR VENTILATION ZONE KEY PLAN

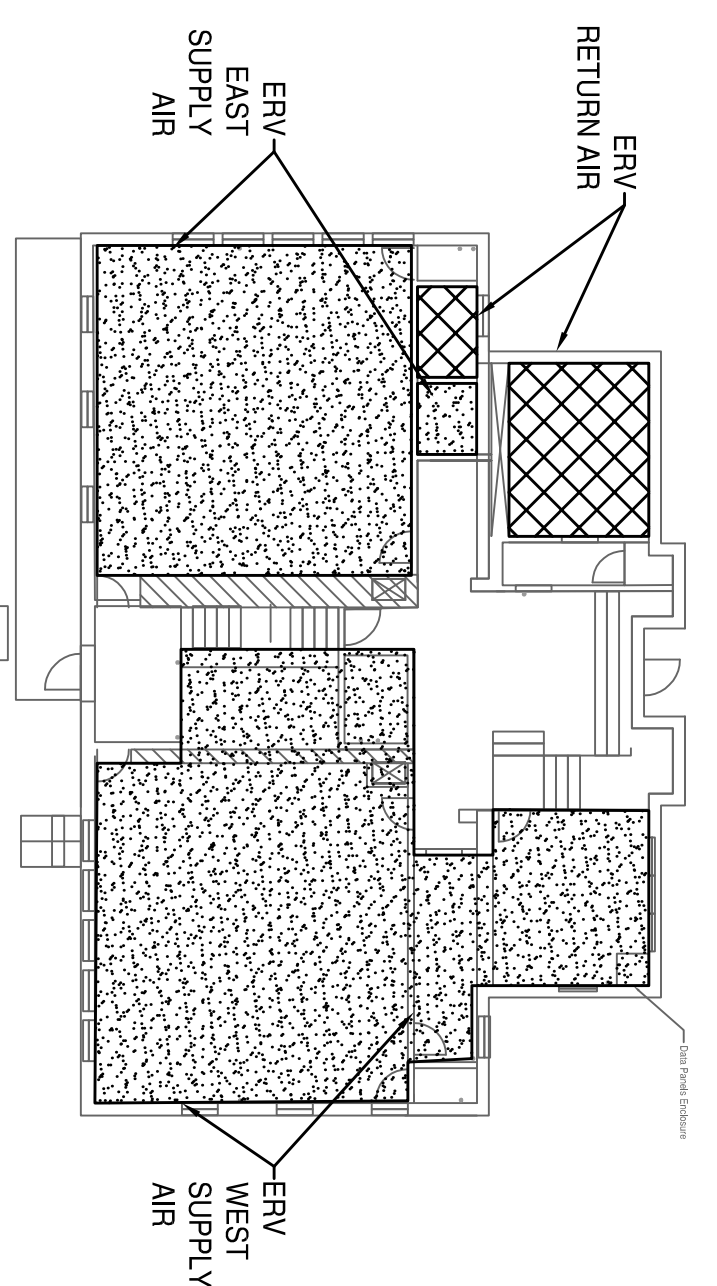

Project North

DRAWING TITLE
1ST FLOOR PLAN
WITH ZONING KEY PLANS

JOB TITLE
COMMUNITY ACTION HEAD START
HVAC UPGRADES
34 CENTRAL ST
TURNER'S FALLS, MA 01376

ENGINEER
SENSIBLE SOLUTIONS
64 KNIGHTLY RD
HAOLEY, MA.
TEL.: (413) 549-5593
CELL.: (413) 427-7290
PO BOX 905 BRATTLEBORO, VT 05302

REVISIONS:

BID SET
DRAWING NO.
H5

SCALE
AS SHOWN
DATE
MAY, 2022